


ALL DIMENSIONS SHOWN ARE
IN METRES AND/OR MILLIMETRES
UNLESS OTHERWISE NOTED.


NOTE:
THIS DRAWING IS PROVIDED FOR INSTRUCTIONAL DESIGN PURPOSES ONLY BASED ON METROLINX GO TRANSIT DESIGN GUIDELINES AND REQUIREMENTS. THE CONSULTANT SHALL VERIFY FOR LOCAL CODE COMPLIANCE, EXISTING SITE CONDITIONS AND INTER DISCIPLINARY DRAWING COORDINATION. ALL DIMENSIONS AND SPECIFICATIONS SHOULD BE VERIFIED BY CONSULTANT AND/OR CONTRACTOR BEFORE ACTUAL CONSTRUCTION BEGINS.

NOTES:

1. CONDUITS AND FITTINGS SHALL BE RIGID PVC AND SHALL MEET THE REQUIREMENTS OF CSA STANDARD.
2. ANCHOR BOLTS, HEX NUTS AND WASHERS SHALL BE MADE OF SAE 10-30 STEEL AND WILL BE HOT DIP GALVANIZED IN ACCORDANCE WITH CSA STANDARD G-164 SPECIFICATIONS.
3. STUDS WILL BE GIVEN A LIBERAL COATING OF WHITE NON-STAINING GREASE.
4. A SETTING TEMPLATE SHALL BE PROVIDED FOR ACCURATE POSITIONING OF THE ANCHORAGE ASSEMBLY AND CONDUITS WITHIN THE FORM. TEMPLATE TO BE REMOVED AFTER CONCRETE HARDENS.
5. BROKEN LINES INDICATE ADDITIONAL CONDUCTORS FOR TWO, THREE, AND FOUR LUMINAIRES INSTALLATION IN ACCORDANCE WITH PARKING AREA LIGHTING LAYOUT AND WIRING DIAGRAM DRAWINGS.
6. IN-LINE WATERPROOF FUSEHOLDER 600V, 30A WITH BREAKAWAY FEATURE FOR EACH LAMP. GOULD GEB-11-11 C/W WATERPROOF INSULATING BOOTS AND ONE 10 AMP FUSE TYPE KTK 600 VOLTS OR APPROVED EQUAL.

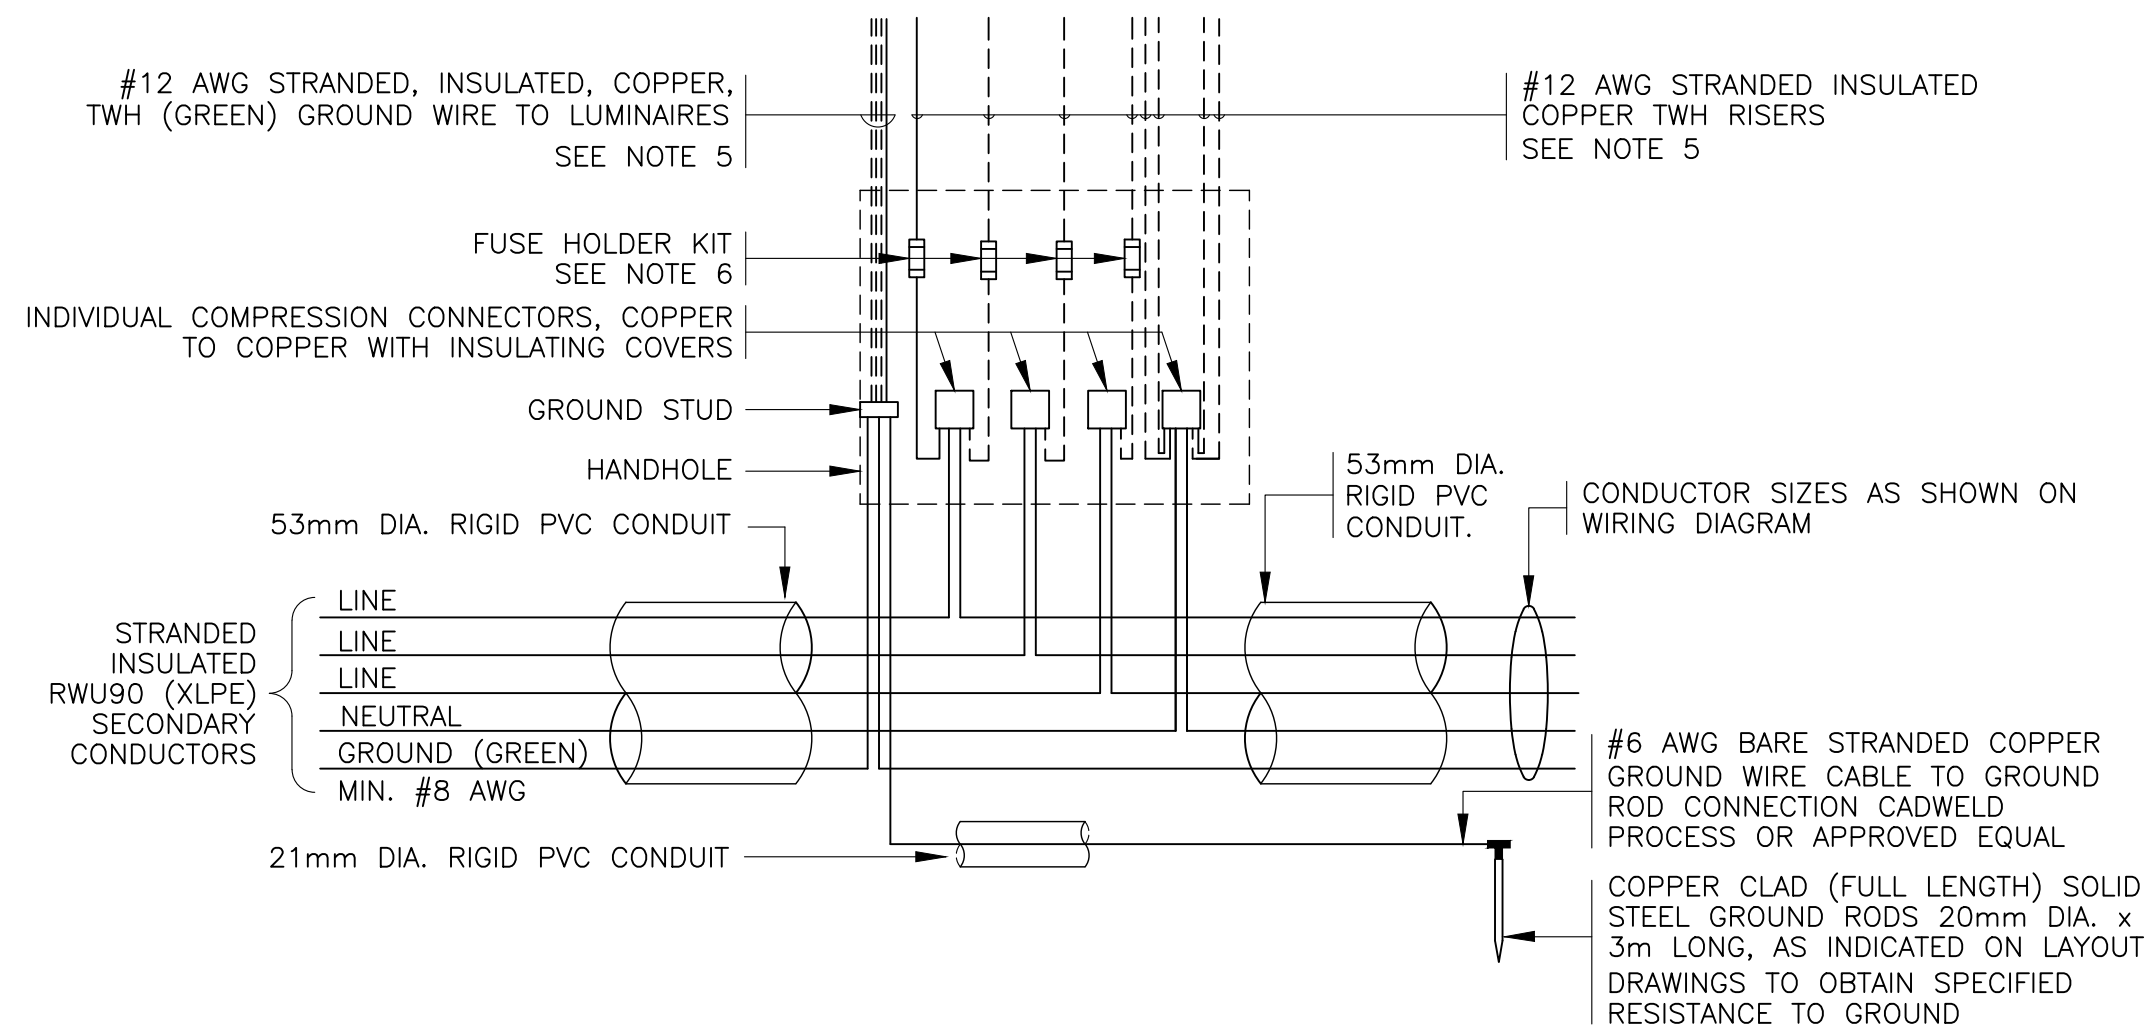

120/208 OR 600/347 VOLT 3-PHASE SYSTEM

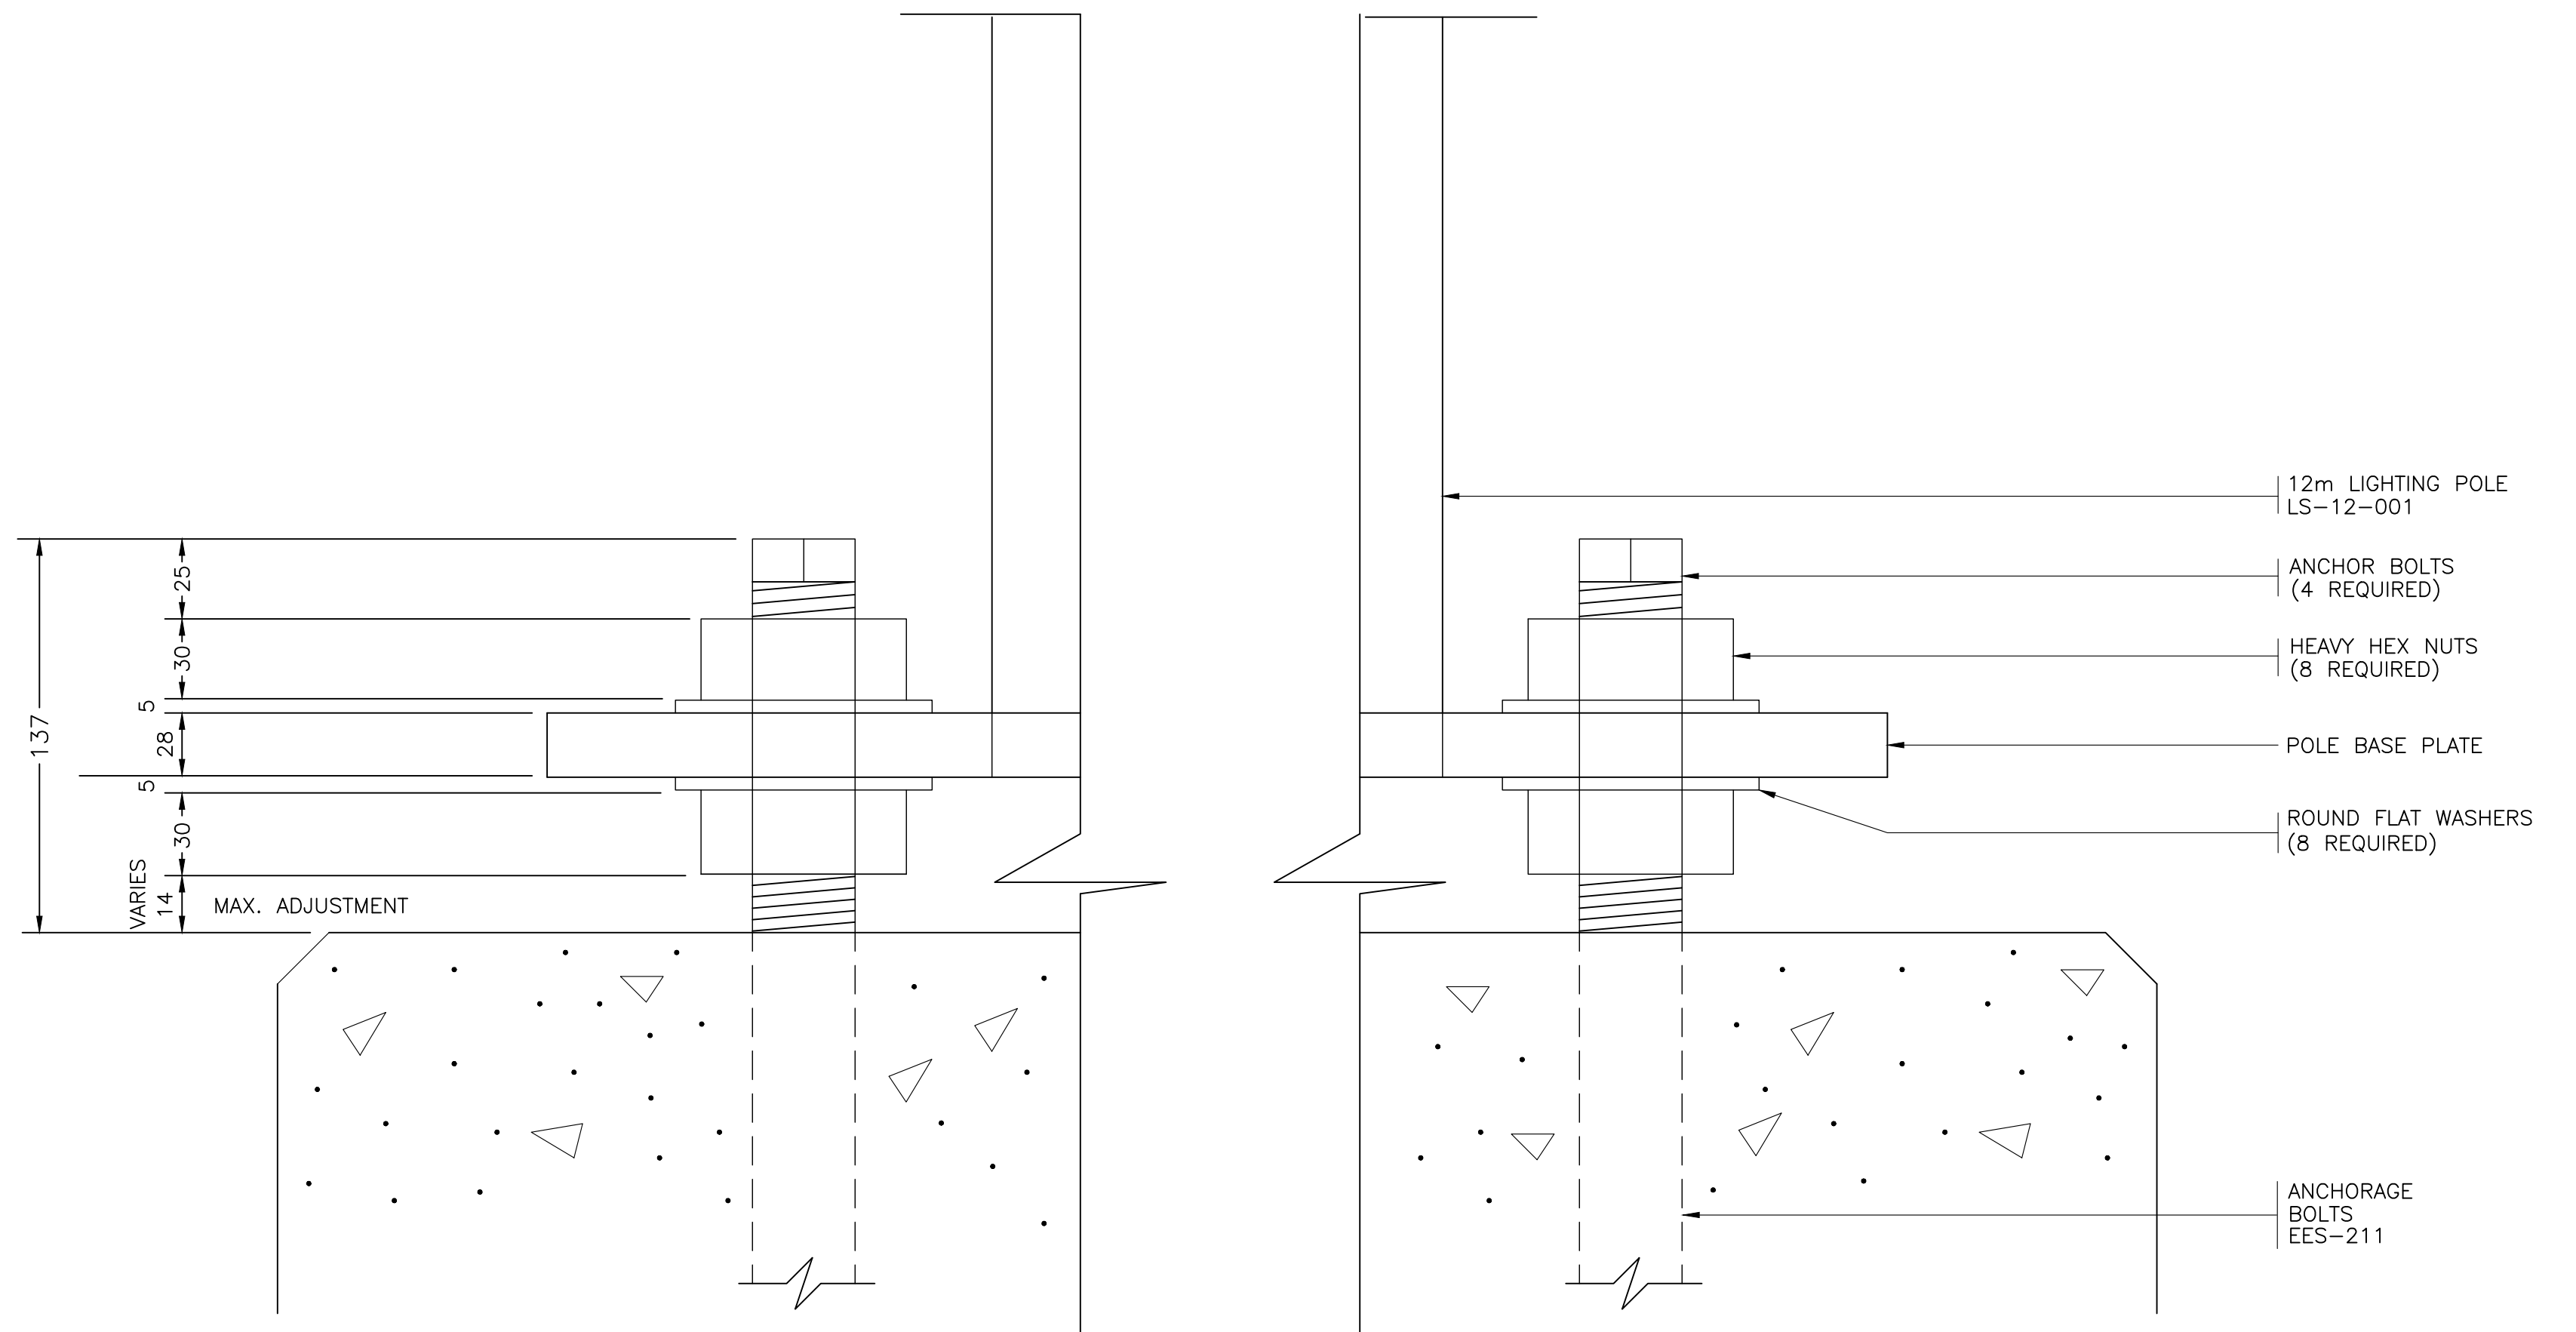

DETAIL

POLE MOUNTING



METROLINX PROJECT NO. XXXXXX

REFERENCE DRAWINGS		ISSUE		REVISIONS		DRAWN BY: X.X.X. YY/MM/DD	DESIGNED BY: YY/MM/DD			 A Division of METROLINX	XXXXXXXXX STATION 12 m LIGHT POLE ANCHORAGE BASE MOUNTING AND WIRING			
						CHECKED BY: YY/MM/DD	APPROVED BY: YY/MM/DD				CONTRACT NO. XX-200X-EN-XXX	DWG. NO. LS 12-003	REV. 1	SHEET
						SCALE: 1:XXX	FULL SIZE ONLY							
DWG NO.	TITLE	NO.	DATE	ISSUED FOR	REV.	DATE	DISCLAIMER NOTE							