



ALL DIMENSIONS SHOWN ARE
IN METRES AND/OR MILLIMETRES
UNLESS OTHERWISE NOTED.

 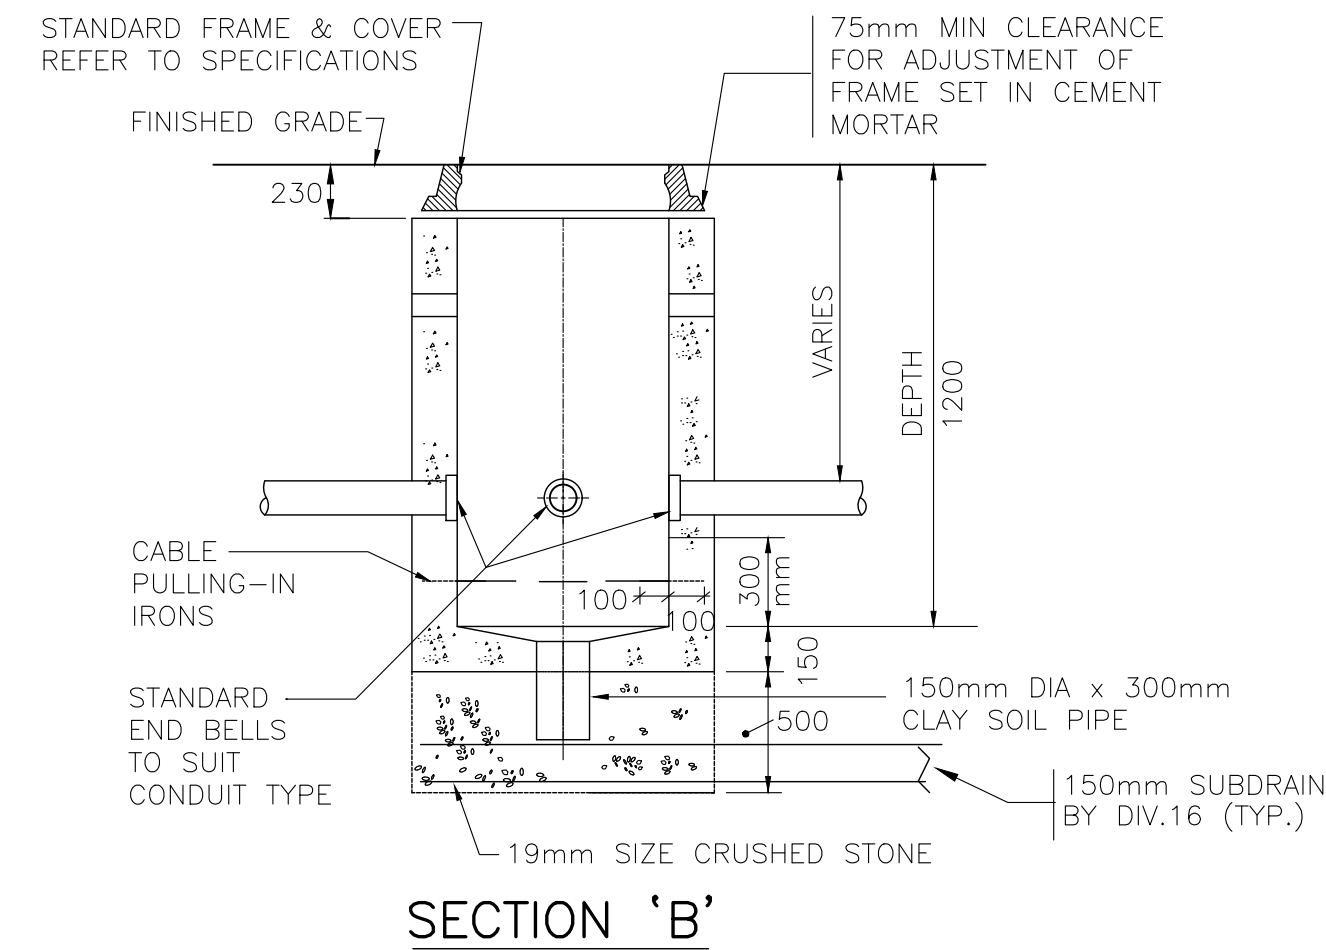


4

5

1. LS-12R-001 ASSEMBLY DETAIL
2. LS-12R-002 RING AND HEADFRAME ASSEMBLY
3. LS-12R-004 CONCRETE FOUNDATION DIMENSIONS AND REINFORCEMENT DETAILS
4. LS-12R-005 POLE BASE AND ANCHORAGE DETAILS
5. LS-12R-006 WIRING DIAGRAMS

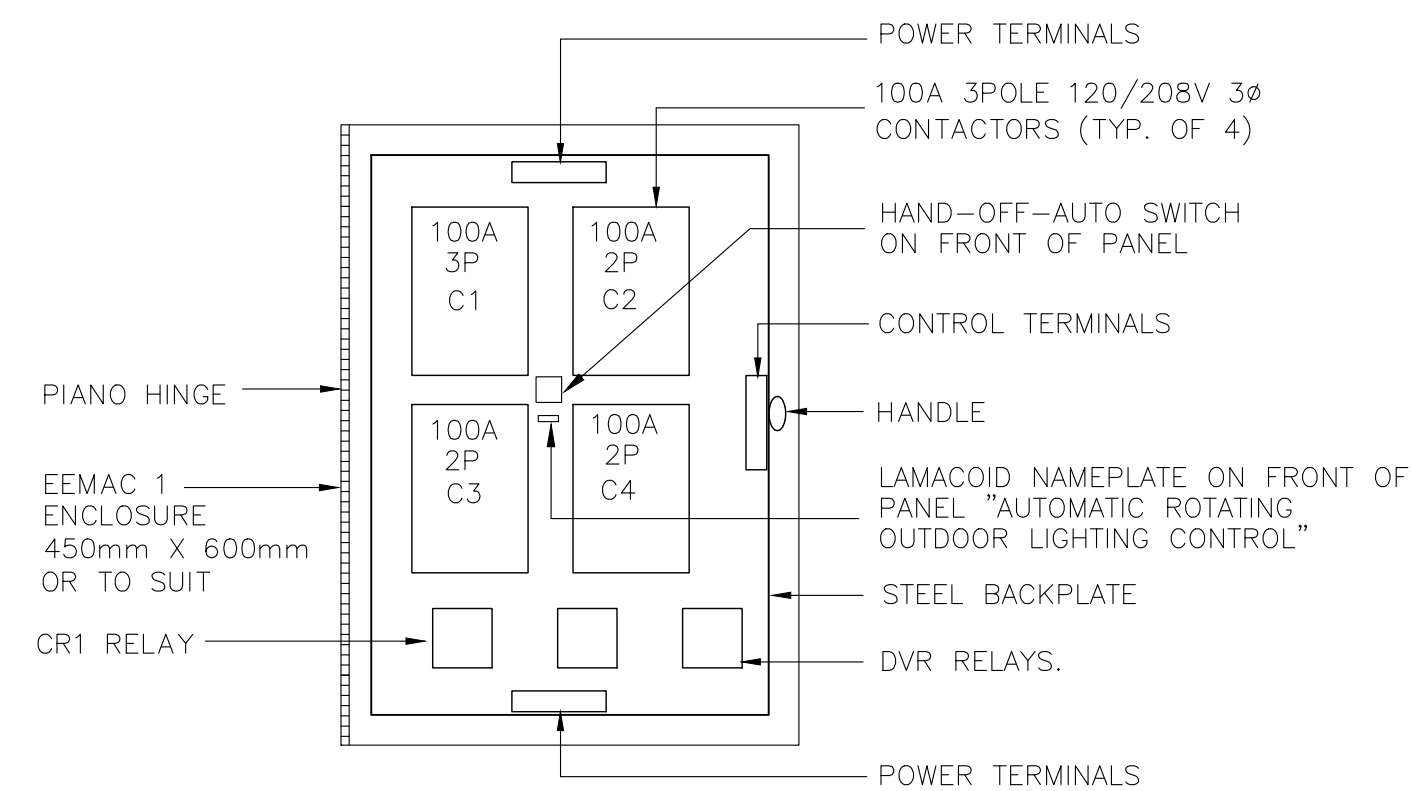

6

AutoCAD drawing: LS 12R-003.dwg Aug 01/18 8:07pm

REFERENCE DRAWINGS		ISSUE		REVISIONS		DRAWN BY: X.X.X. YY/MM/DD	DESIGNED BY: YY/MM/DD			 A Division of METROLINX	XXXXXXXXX STATION 12m LIGHT POLE WITH RING & LOWERING DEVICE ELECTRICAL MISC. DETAILS			
						CHECKED BY: YY/MM/DD	APPROVED BY: YY/MM/DD				CONTRACT NO. XX-200X-EN-XXX	DWG. NO. LS 12R-003	REV. 0	SHEET
DWG NO.	TITLE	NO.	DATE	ISSUED FOR	REV.	DATE	SCALE: 1:XXX	FULL SIZE ONLY						