


LEFT HAND TURNOUT

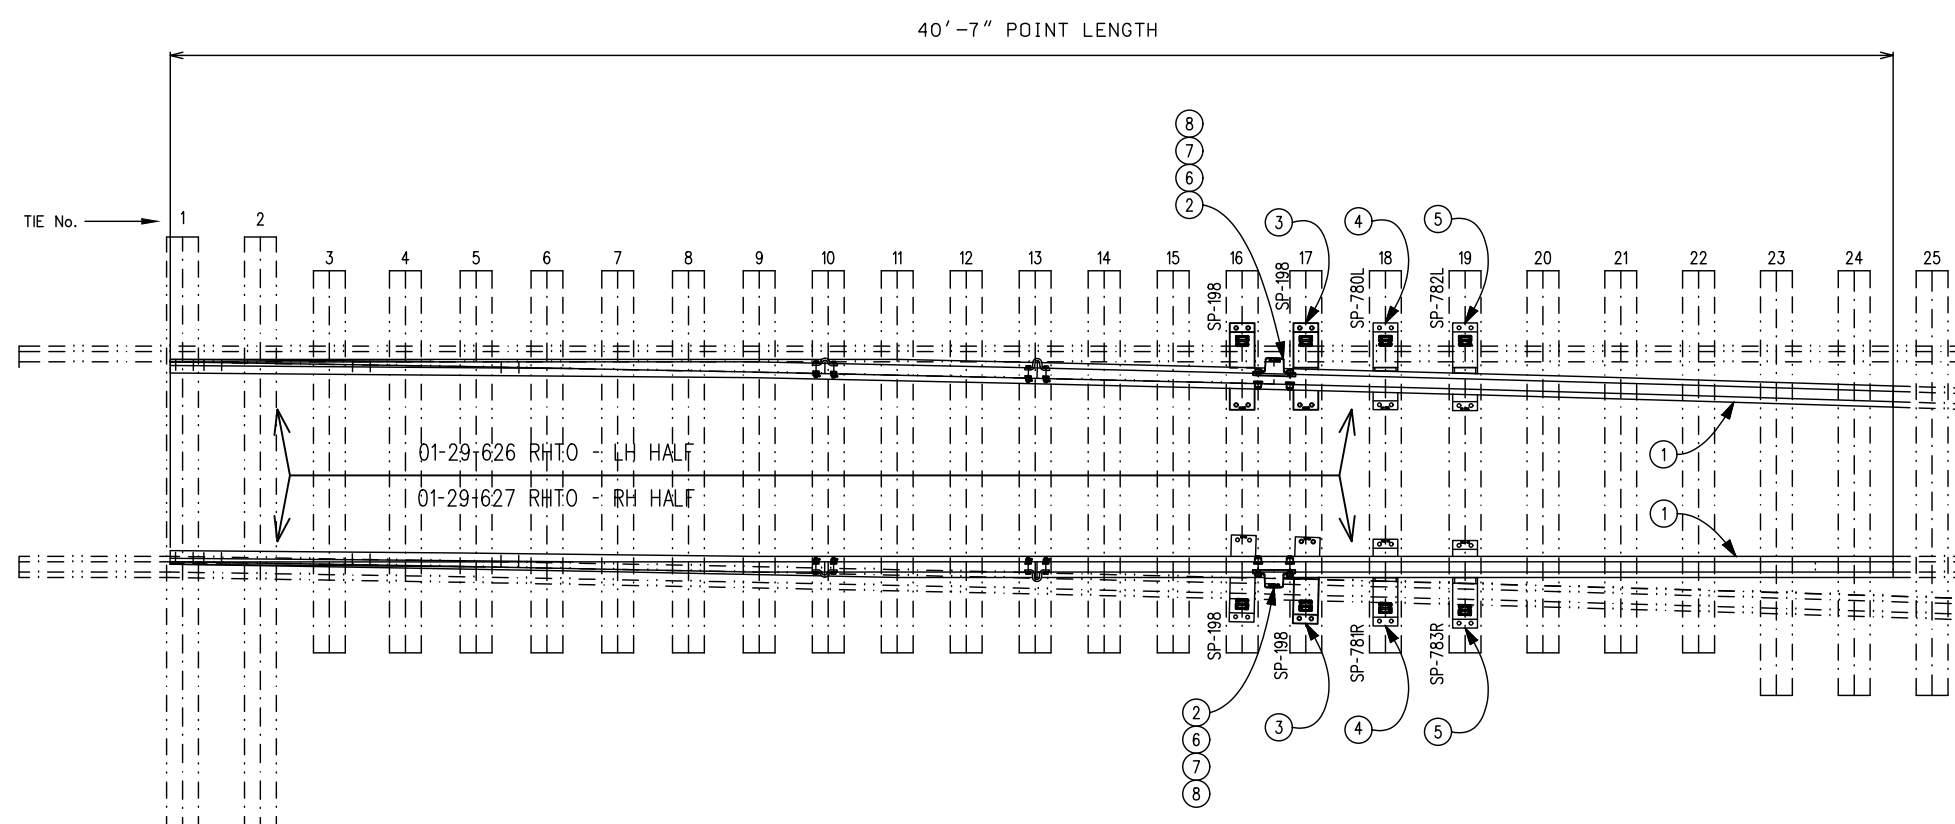

RIGHT HAND TURNOUT

BILL OF MATERIALS - LEFT HAND TURNOUT - LEFT HALF RETROFIT KIT

ITEM No.	DESCRIPTION	QTY.	STANDARD DWG. No.
1	L.H. STRAIGHT SAMSON SWITCH POINT, 136TW, 40'-7" LONG	1	GTS-0377
2	SWITCH HEEL BLOCK FOR 136TW RAIL, FLOATING STYLE	1	GTS-0383
3	SWITCH PLATE SP-198	2	GTS-0530
4	SWITCH PLATE SP-781L	1	GTS-0588
5	SWITCH PLATE SP-783L	1	GTS-0588
6	HEEL BLOCK BOLT, 1-1/8" DIA. X 5-1/2" LONG, 7 UNC C/W NUT	2	GTS-1308
7	HEEL BLOCK SPRING WASHER FOR 1-1/8" DIA. BOLT	2	GTS-1301
8	HEEL BLOCK LOCKNUT FOR 1-1/8" DIA. - 7 UNC BOLT	2	GTS-1302

BILL OF MATERIALS - LEFT HAND TURNOUT - RIGHT HALF RETROFIT KIT

ITEM No.	DESCRIPTION	QTY.	STANDARD DWG. No.
1	R.H. CURVED SAMSON SWITCH POINT, 136TW, 40'-7" LONG	1	GTS-0377
2	SWITCH HEEL BLOCK FOR 136TW RAIL, FLOATING STYLE	1	GTS-0383
3	SWITCH PLATE SP-198	2	GTS-0530
4	SWITCH PLATE SP-780R	1	GTS-0589
5	SWITCH PLATE SP-782R	1	GTS-0589
6	HEEL BLOCK BOLT, 1-1/8" DIA. X 5-1/2" LONG, 7 UNC C/W NUT	2	GTS-1308
7	HEEL BLOCK SPRING WASHER FOR 1-1/8" DIA. BOLT	2	GTS-1301
8	HEEL BLOCK LOCKNUT FOR 1-1/8" DIA. - 7 UNC BOLT	2	GTS-1302

BILL OF MATERIALS - RIGHT HAND TURNOUT - LEFT HALF RETROFIT KIT

ITEM No.	DESCRIPTION	QTY.	STANDARD DWG. No.
1	L.H. CURVED SAMSON SWITCH POINT, 136TW, 40'-7" LONG	1	GTS-0377
2	SWITCH HEEL BLOCK FOR 136TW RAIL, FLOATING STYLE	1	GTS-0383
3	SWITCH PLATE SP-198	2	GTS-0530
4	SWITCH PLATE SP-780L	1	GTS-0589
5	SWITCH PLATE SP-782L	1	GTS-0589
6	HEEL BLOCK BOLT, 1-1/8" DIA. X 5-1/2" LONG, 7 UNC C/W NUT	2	GTS-1308
7	HEEL BLOCK SPRING WASHER FOR 1-1/8" DIA. BOLT	2	GTS-1301
8	HEEL BLOCK LOCKNUT FOR 1-1/8" DIA. - 7 UNC BOLT	2	GTS-1302

BILL OF MATERIALS - RIGHT HAND TURNOUT - RIGHT HALF RETROFIT KIT

ITEM No.	DESCRIPTION	QTY.	STANDARD DWG. No.
1	R.H. STRAIGHT SAMSON SWITCH POINT, 136TW, 40'-7" LONG	1	GTS-0377
2	SWITCH HEEL BLOCK FOR 136TW RAIL, FLOATING STYLE	1	GTS-0383
3	SWITCH PLATE SP-198	2	GTS-0530
4	SWITCH PLATE SP-781R	1	GTS-0588
5	SWITCH PLATE SP-783R	1	GTS-0588
6	HEEL BLOCK BOLT, 1-1/8" DIA. X 5-1/2" LONG, 7 UNC C/W NUT	2	GTS-1308
7	HEEL BLOCK SPRING WASHER FOR 1-1/8" DIA. BOLT	2	GTS-1301
8	HEEL BLOCK LOCKNUT FOR 1-1/8" DIA. - 7 UNC BOLT	2	GTS-1302

METRIC CONVERSION: 1 inch=25.4mm, 1 foot=304.8mm

No.	Date	Revision	By	Approved
1	18/07/27	ADDED IMPERIAL TO METRIC CONVERSION NOTE		

Standard / SWITCH RETROFIT KIT, 136 TW RAIL  
 26' GEOMETRY/40'7" LONG BOLTED DESIGN  
 GTS-0251 LATERAL TURNOUT ON WOOD TIES  
 POWER LAYOUT, #16 TURNOUT

Drawn LG Checked VC Approved *[Signature]*  
 VP Engineering & Asset Management



Date SEPT 15/2017 Plan Number GTS-0391 Rev 1