


LEFT HAND TURNOUT

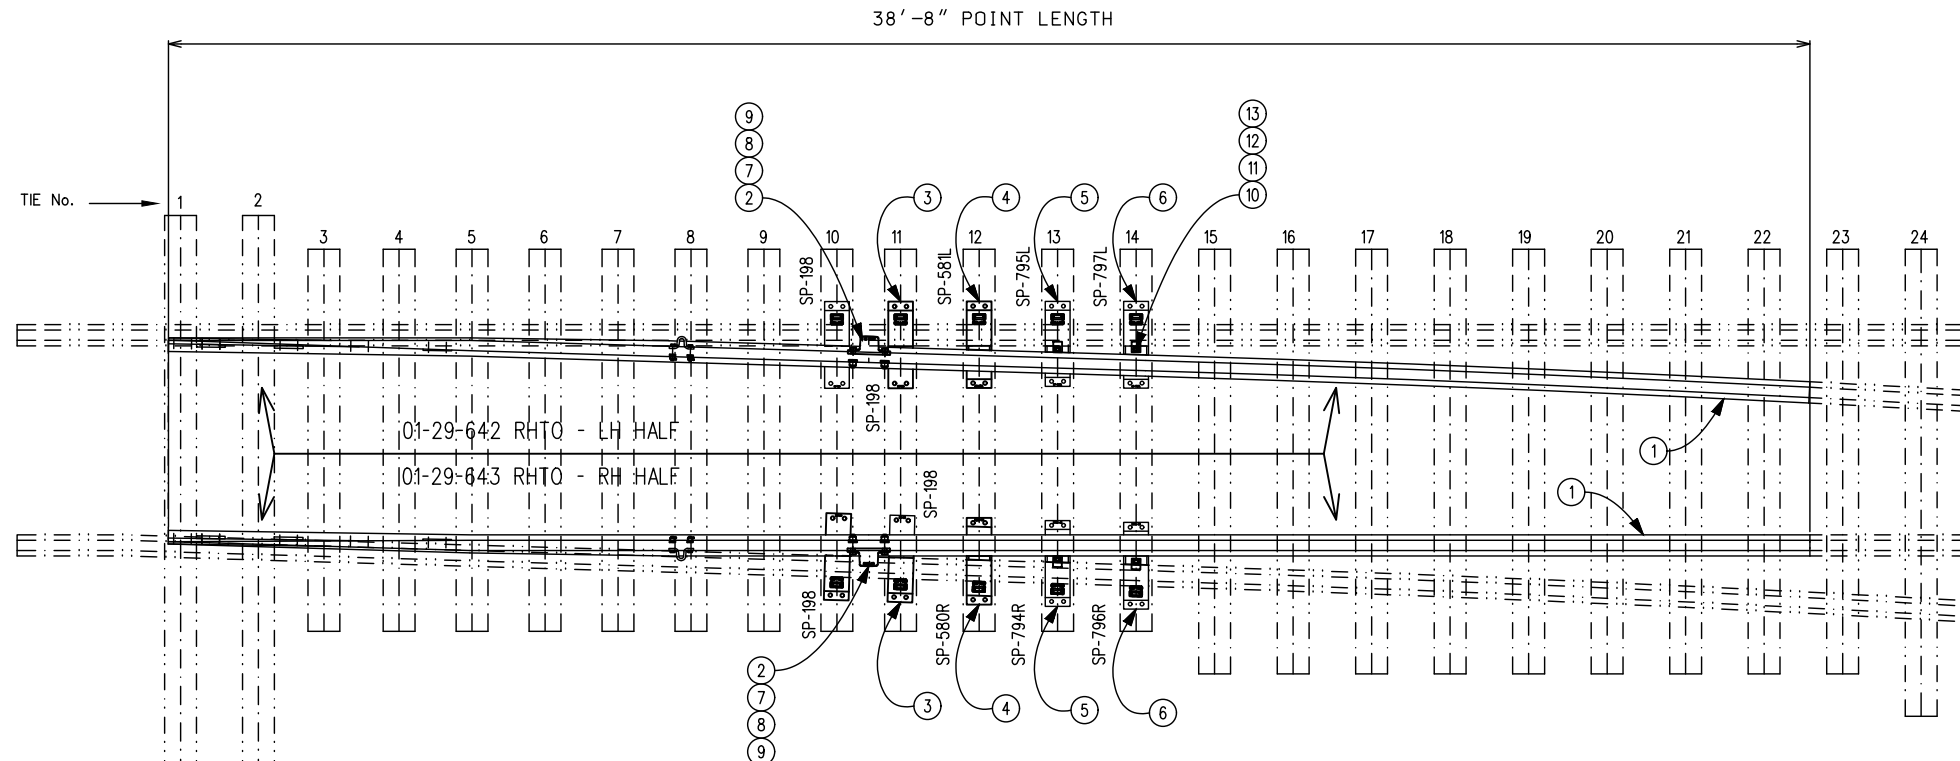

RIGHT HAND TURNOUT

BILL OF MATERIALS - LEFT HAND TURNOUT - LEFT HALF RETROFIT KIT

ITEM No.	DESCRIPTION	QTY.	STANDARD DWG. No.
1	L.H. SAMSON STRAIGHT SPRING SWITCH POINT, 136TW, 38'-8" LONG	1	GTS-0368
2	SWITCH HEEL BLOCK FOR 136TW RAIL, FLOATING STYLE	1	GTS-0383
3	SWITCH PLATE SP-198	2	GTS-0530
4	SWITCH PLATE SP-580L	1	GTS-0588
5	SWITCH PLATE SP-794L	1	GTS-0592
6	SWITCH PLATE SP-796L	1	GTS-0592
7	HEEL BLOCK BOLT, 1-1/8" DIA. x 5-1/2" LONG, 7 UNC C/W NUT	2	GTS-1308
8	HEEL BLOCK SPRING WASHER FOR 1-1/8" DIA. BOLT	2	GTS-1301
9	HEEL BLOCK LOCKNUT FOR 1-1/8" DIA. - 7 UNC BOLT	2	GTS-1302
10	HOLD DOWN CLIP - FS 156	2	GTS-1334
11	1" DIA. - 8 UNC SQ. HEAD SQ. NECK CARRIAGE BOLT X 3-1/2" LG.	2	GTS-1307/1
12	SPRING WASHER FOR 1" DIA. BOLT	2	GTS-1301
13	LOCKNUT FOR 1" DIA. - 8 UNC BOLT	2	GTS-1302

BILL OF MATERIALS - LEFT HAND TURNOUT - RIGHT HALF RETROFIT KIT

ITEM No.	DESCRIPTION	QTY.	STANDARD DWG. No.
1	R.H. SAMSON CURVED SPRING SWITCH POINT, 136TW, 38'-8" LONG	1	GTS-0368
2	SWITCH HEEL BLOCK FOR 136TW RAIL, FLOATING STYLE	1	GTS-0383
3	SWITCH PLATE SP-198	2	GTS-0530
4	SWITCH PLATE SP-581R	1	GTS-0589
5	SWITCH PLATE SP-795R	1	GTS-0593
6	SWITCH PLATE SP-797R	1	GTS-0593
7	HEEL BLOCK BOLT, 1-1/8" DIA. x 5-1/2" LONG, 7 UNC C/W NUT	2	GTS-1308
8	HEEL BLOCK SPRING WASHER FOR 1-1/8" DIA. BOLT	2	GTS-1301
9	HEEL BLOCK LOCKNUT FOR 1-1/8" DIA. - 7 UNC BOLT	2	GTS-1302
10	HOLD DOWN CLIP - FS 156	2	GTS-1334
11	1" DIA. - 8 UNC SQ. HEAD SQ. NECK CARRIAGE BOLT X 3-1/2" LG.	2	GTS-1307/1
12	SPRING WASHER FOR 1" DIA. BOLT	2	GTS-1301
13	LOCKNUT FOR 1" DIA. - 8 UNC BOLT	2	GTS-1302

BILL OF MATERIALS - RIGHT HAND TURNOUT - LEFT HALF RETROFIT KIT

ITEM No.	DESCRIPTION	QTY.	STANDARD DWG. No.
1	L.H. SAMSON CURVED SPRING SWITCH POINT, 136TW, 38'-8" LONG	1	GTS-0368
2	SWITCH HEEL BLOCK FOR 136TW RAIL, FLOATING STYLE	1	GTS-0383
3	SWITCH PLATE SP-198	2	GTS-0530
4	SWITCH PLATE SP-581L	1	GTS-0589
5	SWITCH PLATE SP-795L	1	GTS-0593
6	SWITCH PLATE SP-797L	1	GTS-0593
7	HEEL BLOCK BOLT, 1-1/8" DIA. x 5-1/2" LONG, 7 UNC C/W NUT	2	GTS-1308
8	HEEL BLOCK SPRING WASHER FOR 1-1/8" DIA. BOLT	2	GTS-1301
9	HEEL BLOCK LOCKNUT FOR 1-1/8" DIA. - 7 UNC BOLT	2	GTS-1302
10	HOLD DOWN CLIP - FS 156	2	GTS-1334
11	1" DIA. - 8 UNC SQ. HEAD SQ. NECK CARRIAGE BOLT X 3-1/2" LG.	2	GTS-1307/1
12	SPRING WASHER FOR 1" DIA. BOLT	2	GTS-1301
13	LOCKNUT FOR 1" DIA. - 8 UNC BOLT	2	GTS-1302

BILL OF MATERIALS - RIGHT HAND TURNOUT - RIGHT HALF RETROFIT KIT

ITEM No.	DESCRIPTION	QTY.	STANDARD DWG. No.
1	R.H. SAMSON STRAIGHT SPRING SWITCH POINT, 136TW, 38'-8" LONG	1	GTS-0368
2	SWITCH HEEL BLOCK FOR 136TW RAIL, FLOATING STYLE	1	GTS-0383
3	SWITCH PLATE SP-198	2	GTS-0530
4	SWITCH PLATE SP-580R	1	GTS-0588
5	SWITCH PLATE SP-794R	1	GTS-0592
6	SWITCH PLATE SP-796R	1	GTS-0592
7	HEEL BLOCK BOLT, 1-1/8" DIA. x 5-1/2" LONG, 7 UNC C/W NUT	2	GTS-1308
8	HEEL BLOCK SPRING WASHER FOR 1-1/8" DIA. BOLT	2	GTS-1301
9	HEEL BLOCK LOCKNUT FOR 1-1/8" DIA. - 7 UNC BOLT	2	GTS-1302
10	HOLD DOWN CLIP - FS 156	2	GTS-1334
11	1" DIA. - 8 UNC SQ. HEAD SQ. NECK CARRIAGE BOLT X 3-1/2" LG.	2	GTS-1307/1
12	SPRING WASHER FOR 1" DIA. BOLT	2	GTS-1301
13	LOCKNUT FOR 1" DIA. - 8 UNC BOLT	2	GTS-1302

METRIC CONVERSION: 1 inch=25.4mm, 1 foot=304.8mm

No.	Date	Revision	By Approved
1	18/07/27	ADDED IMPERIAL TO METRIC CONVERSION NOTE	

Standard / SWITCH RETROFIT KIT, 136 TW RAIL
 16'6" GEOMETRY/38'8" LONG BOLTED DESIGN
 GTS-0011 LATERAL TURNOUT ON WOOD TIES
 MANUAL/POWER LAYOUT, *10 TURNOUT

Drawn LG Checked VC Approved *[Signature]*
 VP Engineering & Asset Management



Date SEPT 15/2017 Plan Number GTS-0391 Rev 1