


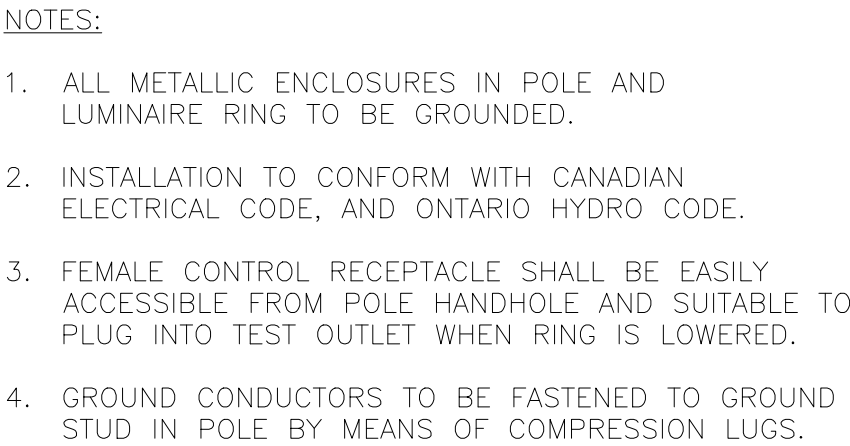

NOTE:
THIS DRAWING IS PROVIDED FOR INSTRUCTIONAL DESIGN PURPOSES ONLY BASED ON METROLINX GO TRANSIT DESIGN GUIDELINES AND REQUIREMENTS. THE CONSULTANT SHALL VERIFY FOR LOCAL CODE COMPLIANCE, EXISTING SITE CONDITIONS AND INTER DISCIPLINARY DRAWING COORDINATION. ALL DIMENSIONS AND SPECIFICATIONS SHOULD BE VERIFIED BY CONSULTANT AND/OR CONTRACTOR BEFORE ACTUAL CONSTRUCTION BEGINS.

WIRING DIAGRAM

- ## 30m LIGHTING POLE STANDARD REFERENCE DRAWINGS

1. LS-30-001 ASSEMBLY DETAIL
2. LS-30-002 RING AND HEADFRAME ASSEMBLY
3. LS-30-003 ELECTRICAL MISCELLANEOUS DETAILS
4. LS-30-004 CONCRETE FOUNDATION DIMENSIONS AND REINFORCEMENT DETAILS
5. LS-30-005 POLE BASE AND ANCHORAGE DETAILS

REFERENCE DRAWINGS		ISSUE		REVISIONS		DRAWN BY: YY/MM/DD	DESIGNED BY: YY/MM/DD		XXXXXXXX STATION 30m (HIGHMAST) LIGHT POLE WIRING DIAGRAM	
						CHECKED BY: YY/MM/DD	APPROVED BY: YY/MM/DD			
				4	24/07/05	REVISED NOTES				
				3						
				2	26/05/14	REVISED LUMINAIRE NOTE				
				1	20/12/13	DISCLAIMER NOTE	SCALE: N.T.S.	FULL SIZE ONLY		
DWG NO.	TITLE	NO.	DATE	ISSUED FOR	REV.	DATE				