


ALL DIMENSIONS SHOWN ARE
IN METRES AND/OR MILLIMETRES
UNLESS OTHERWISE NOTED.


NOTE:
THIS DRAWING IS PROVIDED FOR INSTRUCTIONAL DESIGN PURPOSES
ONLY BASED ON METROLINX GO TRANSIT DESIGN GUIDELINES AND
REQUIREMENTS. THE CONSULTANT SHALL VERIFY FOR LOCAL CODE
COMPLIANCE, EXISTING SITE CONDITIONS AND INTER DISCIPLINARY
DRAWING COORDINATION. ALL DIMENSIONS AND SPECIFICATIONS SHOULD
BE VERIFIED BY CONSULTANT AND/OR CONTRACTOR BEFORE ACTUAL
CONSTRUCTION BEGINS.

NOTES:

1. CONDUITS AND FITTINGS SHALL BE RIGID PVC AND SHALL MEET THE REQUIREMENTS OF CSA STANDARD.
2. ANCHOR BOLTS, HEX NUTS AND WASHERS SHALL BE MADE OF SAE 10-30 STEEL AND WILL BE HOT DIP GALVANIZED IN ACCORDANCE WITH CSA STANDARD G-164 SPECIFICATIONS.
3. STUDS WILL BE GIVEN A LIBERAL COATING OF WHITE NON-STAINING GREASE.
4. A SETTING TEMPLATE SHALL BE PROVIDED FOR ACCURATE POSITIONING OF THE ANCHORAGE ASSEMBLY AND CONDUITS WITHIN THE FORM. TEMPLATE TO BE REMOVED AFTER CONCRETE HARDENS.
5. BROKEN LINES INDICATE ADDITIONAL CONDUCTORS FOR TWO, THREE, AND FOUR LUMINAIRES INSTALLATION IN ACCORDANCE WITH PARKING AREA LIGHTING LAYOUT AND WIRING DIAGRAM DRAWINGS.
6. IN-LINE WATERPROOF FUSEHOLDER 600V, 30A WITH BREAKAWAY FEATURE FOR EACH LAMP. GOULD GEB-11-11 C/W WATERPROOF INSULATING BOOTS AND ONE 10 AMP FUSE TYPE KTK 600 VOLTS OR APPROVED EQUAL.

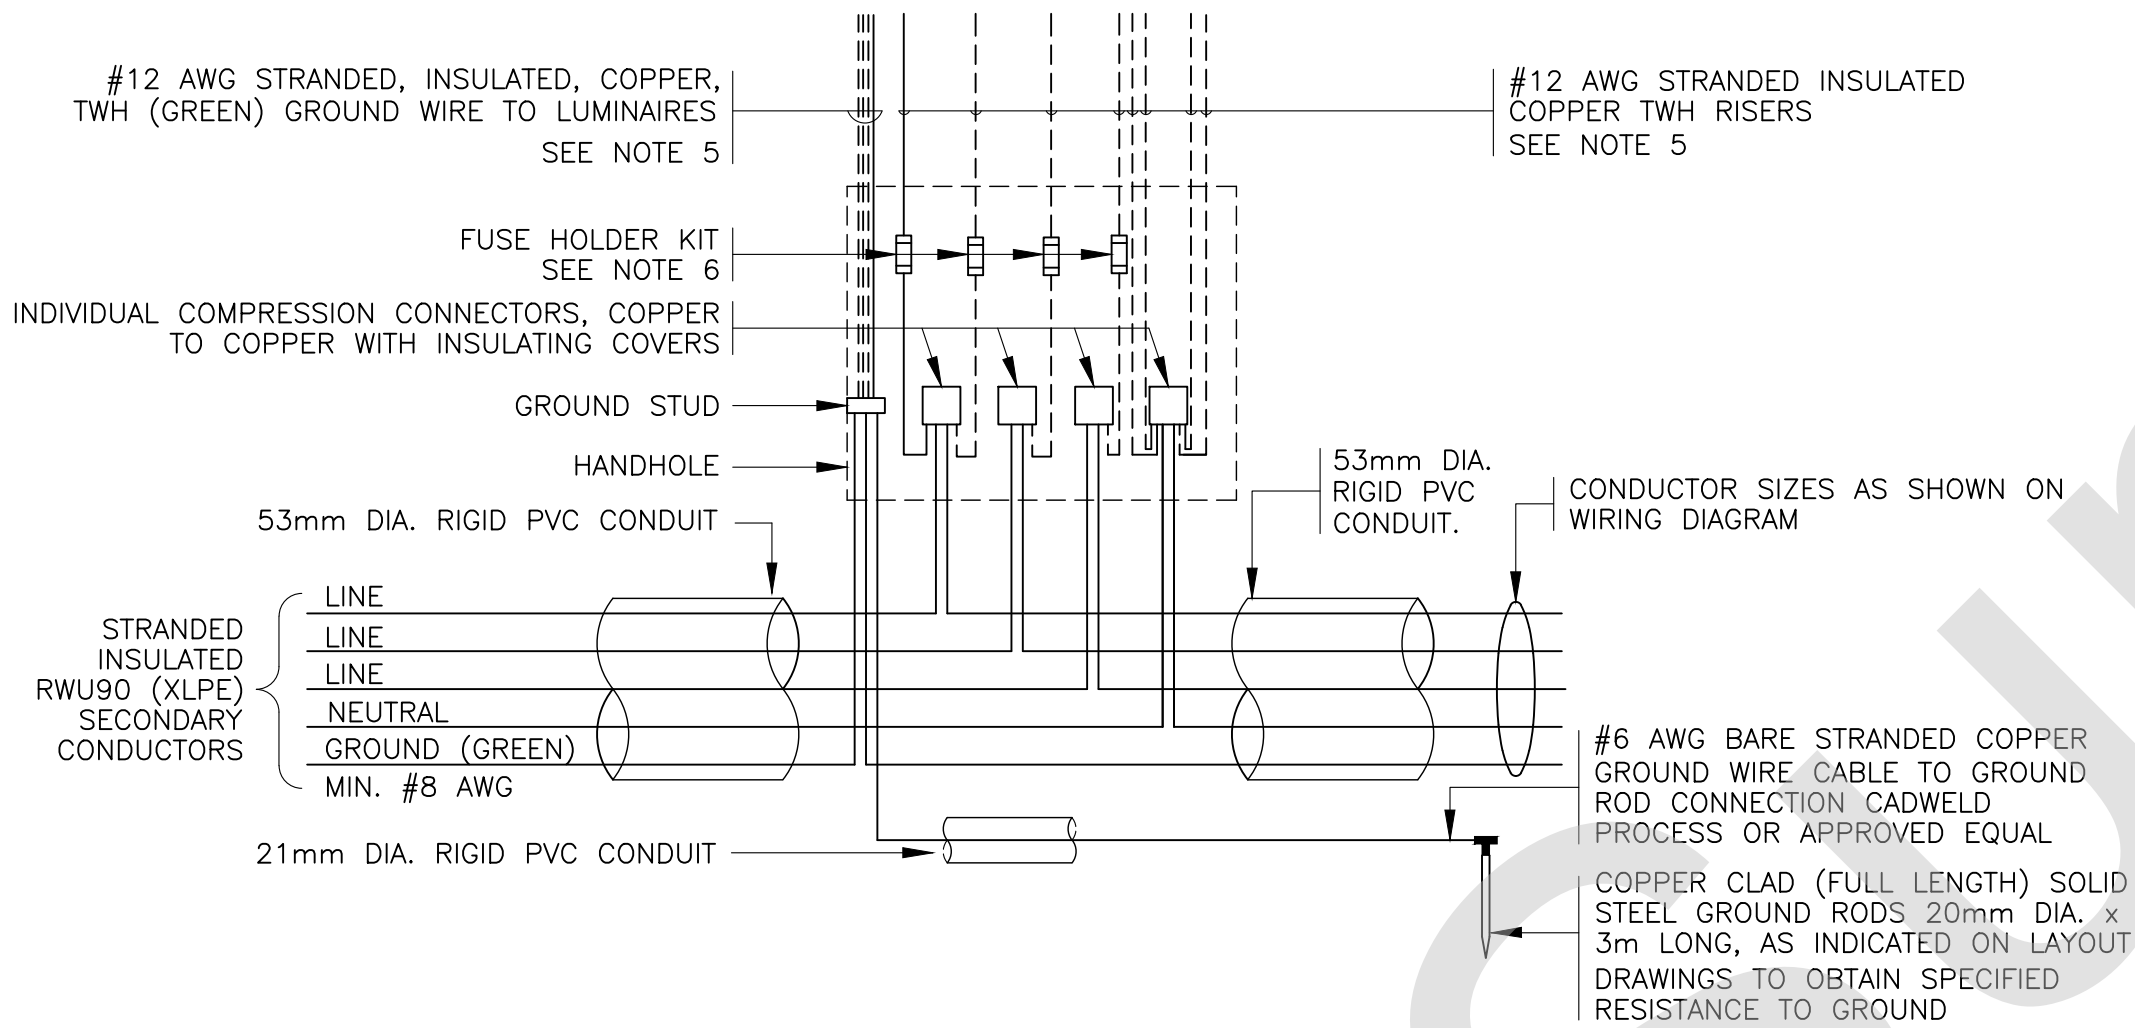


120/208 OR 600/347 VOLT 3-PHASE SYSTEM

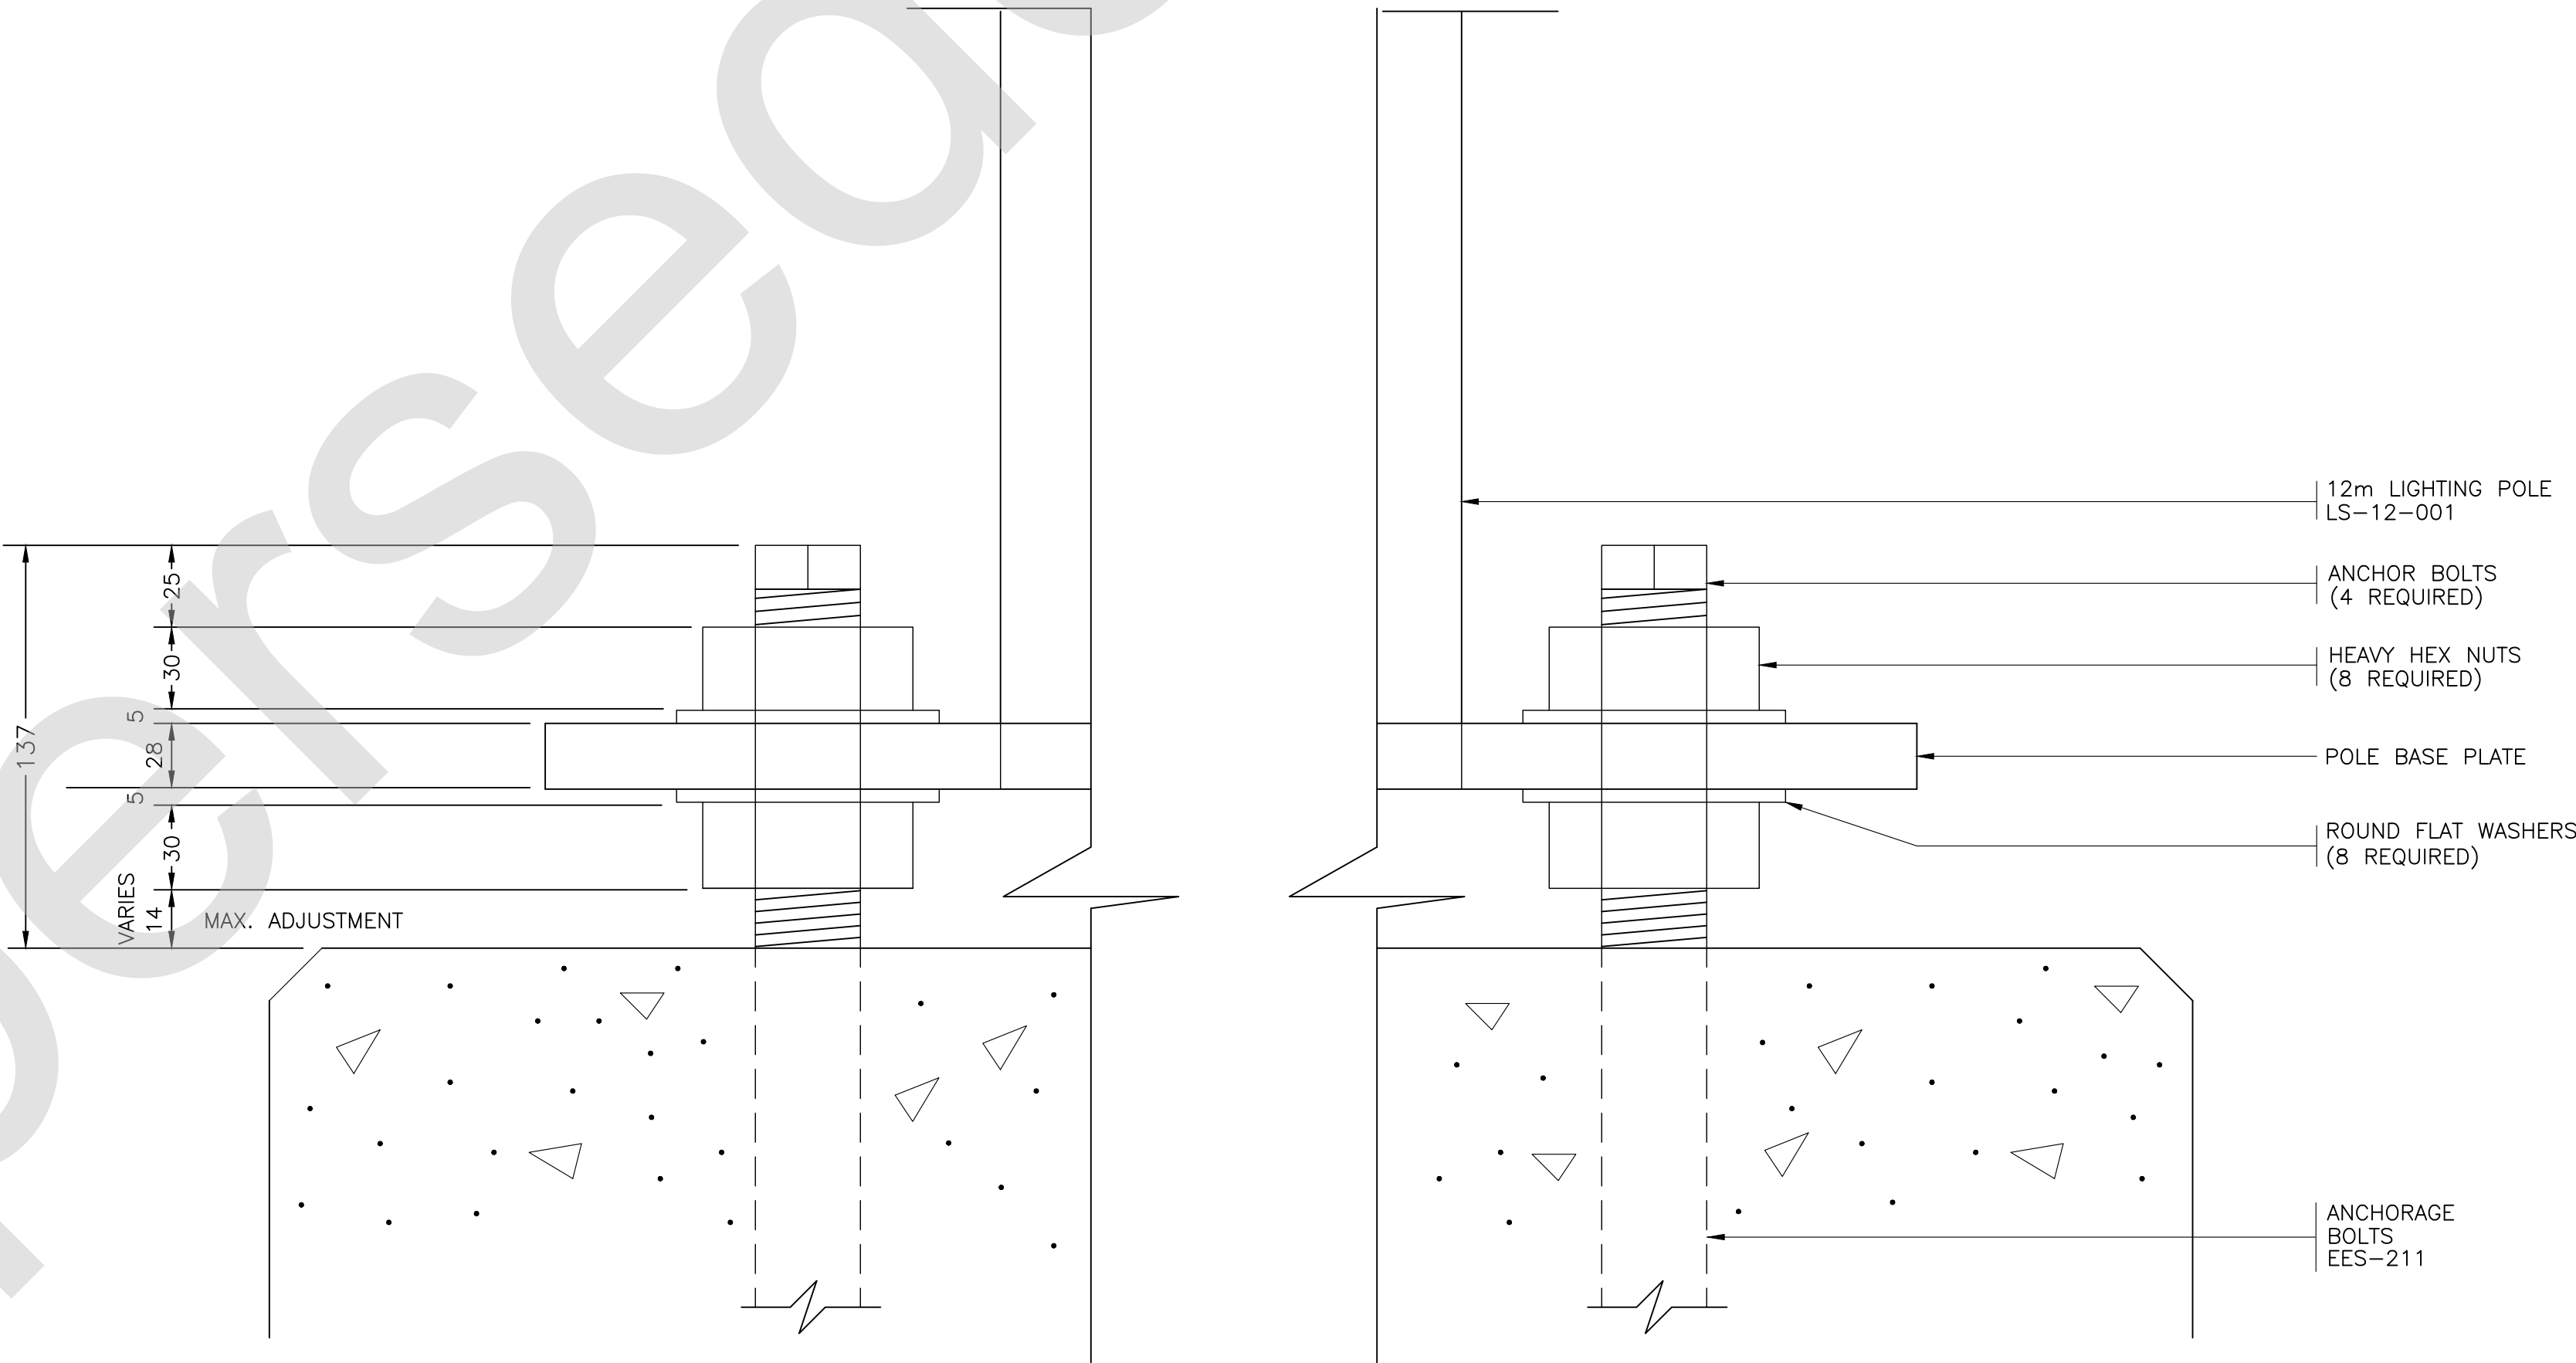

DETAIL
POLE MOUNTING

8
LS-12-003

METROLINX PROJECT NO. XXXXXX

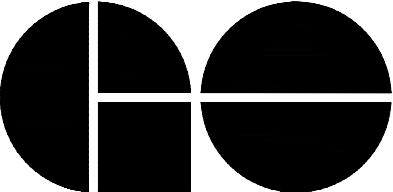REFERENCE DRAWINGS		ISSUE		REVISIONS		DRAWN BY:	DESIGNED BY:	 A Division of METROLINX		XXXXXXXXX STATION 12 m LIGHT POLE ANCHORAGE BASE MOUNTING AND WIRING			
						X.X.X. YY/MM/DD	YY/MM/DD						
						CHECKED BY: YY/MM/DD	APPROVED BY: YY/MM/DD						
						SCALE: 1:XXX	FULL SIZE ONLY						
DWG. NO.	TITLE	NO.	DATE	ISSUED FOR	REV.	DATE	DISCLAIMER NOTE			CONTRACT NO. XX-200X-EN-XXX	DWG. NO. LS 12-003	REV. 1	SHEET